


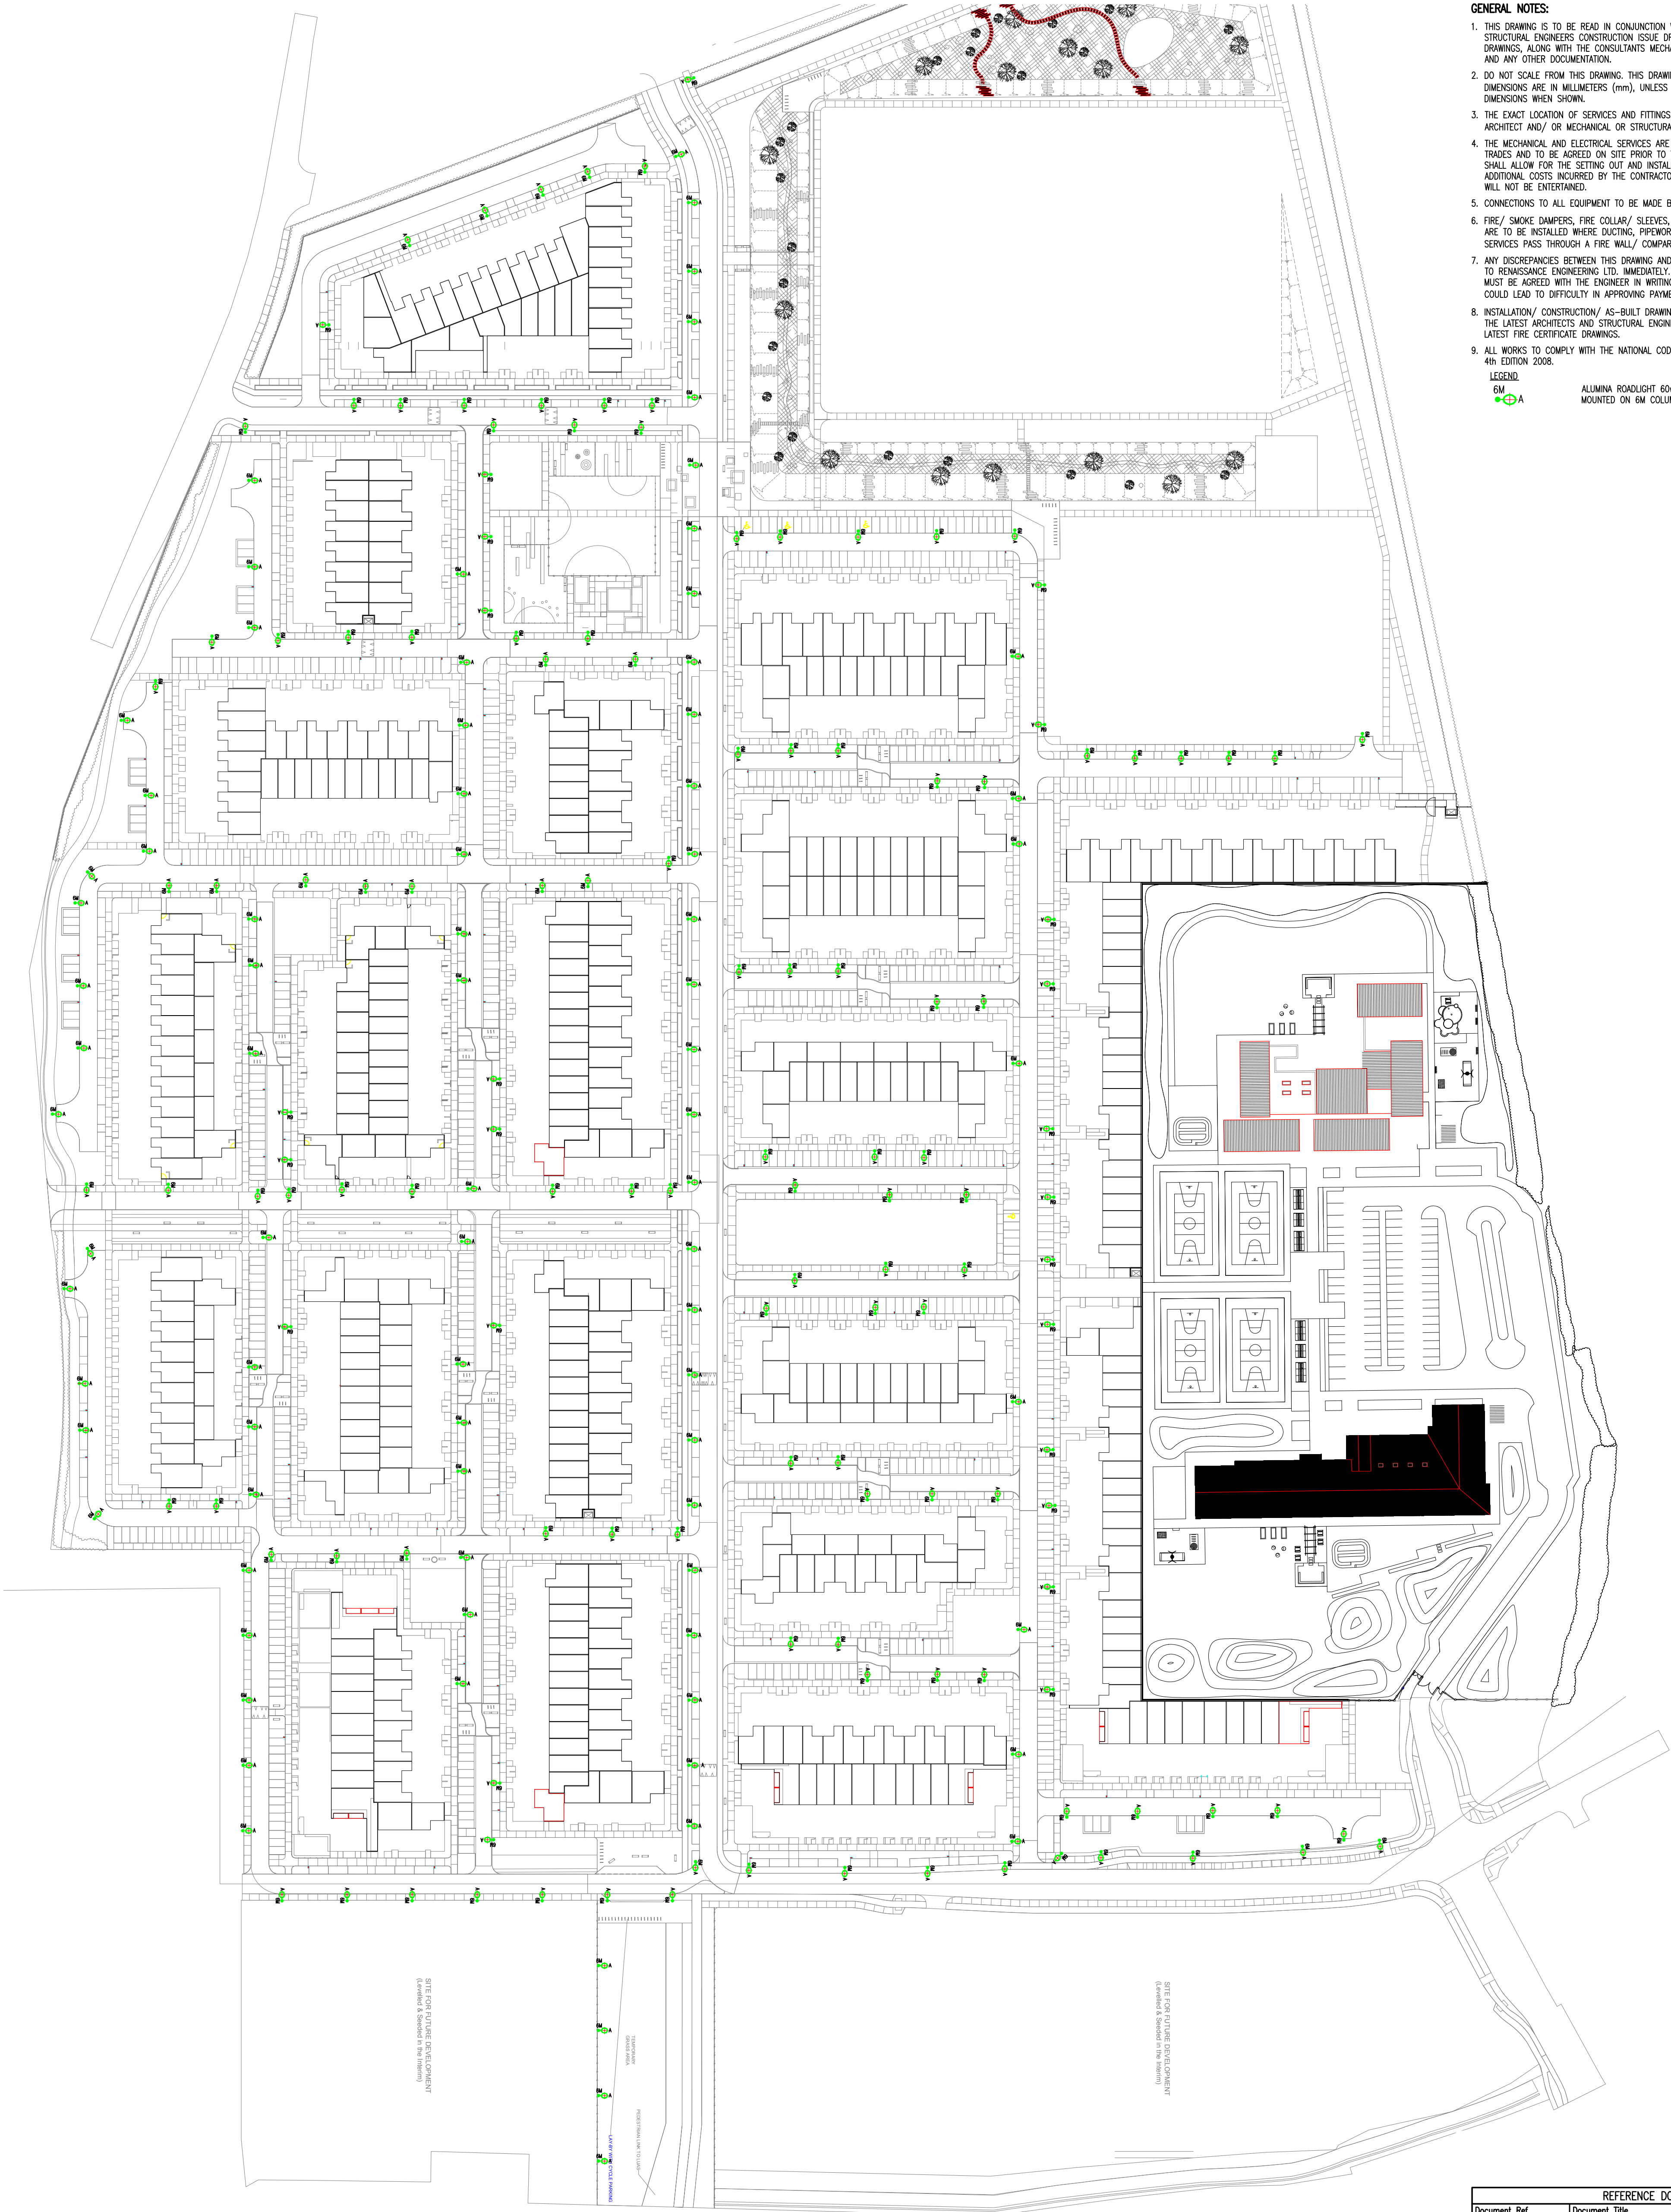


- GENERAL NOTES:**
1. THIS DRAWING IS TO BE READ IN CONJUNCTION WITH ALL RELEVANT ARCHITECTS AND STRUCTURAL ENGINEERS CONSTRUCTION ISSUE DRAWINGS, FIRE CERTIFICATE & FIRE DRAWINGS, ALONG WITH THE CONSULTANTS MECHANICAL AND ELECTRICAL SPECIFICATIONS AND ANY OTHER DOCUMENTATION.
 2. DO NOT SCALE FROM THIS DRAWING. THIS DRAWING IS REPRESENTATIVE ONLY. ALL DIMENSIONS ARE IN MILLIMETERS (mm), UNLESS OTHERWISE STATED. USE THE FIGURED DIMENSIONS WHEN SHOWN.
 3. THE EXACT LOCATION OF SERVICES AND FITTINGS TO BE AGREED ON SITE WITH THE ARCHITECT AND/ OR MECHANICAL OR STRUCTURAL ENGINEER PRIOR TO THEIR INSTALLATION.
 4. THE MECHANICAL AND ELECTRICAL SERVICES ARE TO BE CO-ORDINATED WITH ALL OTHER TRADES AND TO BE AGREED ON SITE PRIOR TO THEIR INSTALLATION. THE CONTRACTOR SHALL ALLOW FOR THE SETTING OUT AND INSTALLATION AROUND ALL OBSTRUCTIONS. ADDITIONAL COSTS INCURRED BY THE CONTRACTOR DUE TO THE LACK OF CO-ORDINATION WILL NOT BE ENTERTAINED.
 5. CONNECTIONS TO ALL EQUIPMENT TO BE MADE BY THE CONTRACTOR.
 6. FIRE/ SMOKE DAMPERS, FIRE COLLAR/ SLEEVES, INTUMESCENT PUTTY AND FIRE BARRIERS ARE TO BE INSTALLED WHERE DUCTING, PIPEWORK, CABLES, CONTAINMENT AND ANY OTHER SERVICES PASS THROUGH A FIRE WALL/ COMPARTMENT OR FLOOR.
 7. ANY DISCREPANCIES BETWEEN THIS DRAWING AND ON SITE CONDITIONS MUST BE REPORTED TO RENAISSANCE ENGINEERING LTD. IMMEDIATELY. ANY CHANGES FROM THIS DESIGN DRAWING MUST BE AGREED WITH THE ENGINEER IN WRITING. A FAILURE TO GAIN THIS APPROVAL COULD LEAD TO DIFFICULTY IN APPROVING PAYMENT FOR THE VARIATION(S).
 8. INSTALLATION/ CONSTRUCTION/ AS-BUILT DRAWINGS TO BE PREPARED WITH REFERENCE TO THE LATEST ARCHITECTS AND STRUCTURAL ENGINEERS CONSTRUCTION ISSUE DRAWINGS AND LATEST FIRE CERTIFICATE DRAWINGS.
 9. ALL WORKS TO COMPLY WITH THE NATIONAL CODE OF PRACTICE FOR CUSTOMER INTERFACE 4th EDITION 2008.
- LEGEND**
- 6M ALUMINA ROADLIGHT 60w LED REF ALU-SL-60 MOUNTED ON 6M COLUMN

SITE FOR FUTURE DEVELOPMENT
(Location & Section in the plan)

SITE FOR FUTURE DEVELOPMENT
(Location & Section in the plan)

REFERENCE DOCUMENTS			
Document Ref.	Document Title	Rev.	
XX	XX	XX	

Rev.	Date	Revision Description	CM	PM/C
P3	15.12.17	ISSUED FOR PLANNING PURPOSES	CM	PM/C

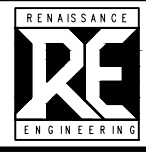

Renaissance Engineering Ltd.
Bond House, 9-10 Lower Bridge Street, Dublin 8.
telephone: +353 (0) 1 675 0850
email: info@reneengie.ie
web: www.renaissanceengineering.ie

Client: GREENACRE RESEDENTIAL DAC

Architect: DARMODY ARCHITECTURE

Job Title: FORTUNESTOWN LANE & GARTER LANE

Drawing Title: SITE LIGHTING LAYOUT
RESEDENTIAL DEVELOPMENT

Date:	Scale:	Job No.:	Drawing No.:	Revision:
05/04/17	1:1000	0A1	17-131	63-S0

Designer:	Checked:	Approved:	CMO Filename:
PM/C	DD	SM	17-131-63-S0.dwg

